






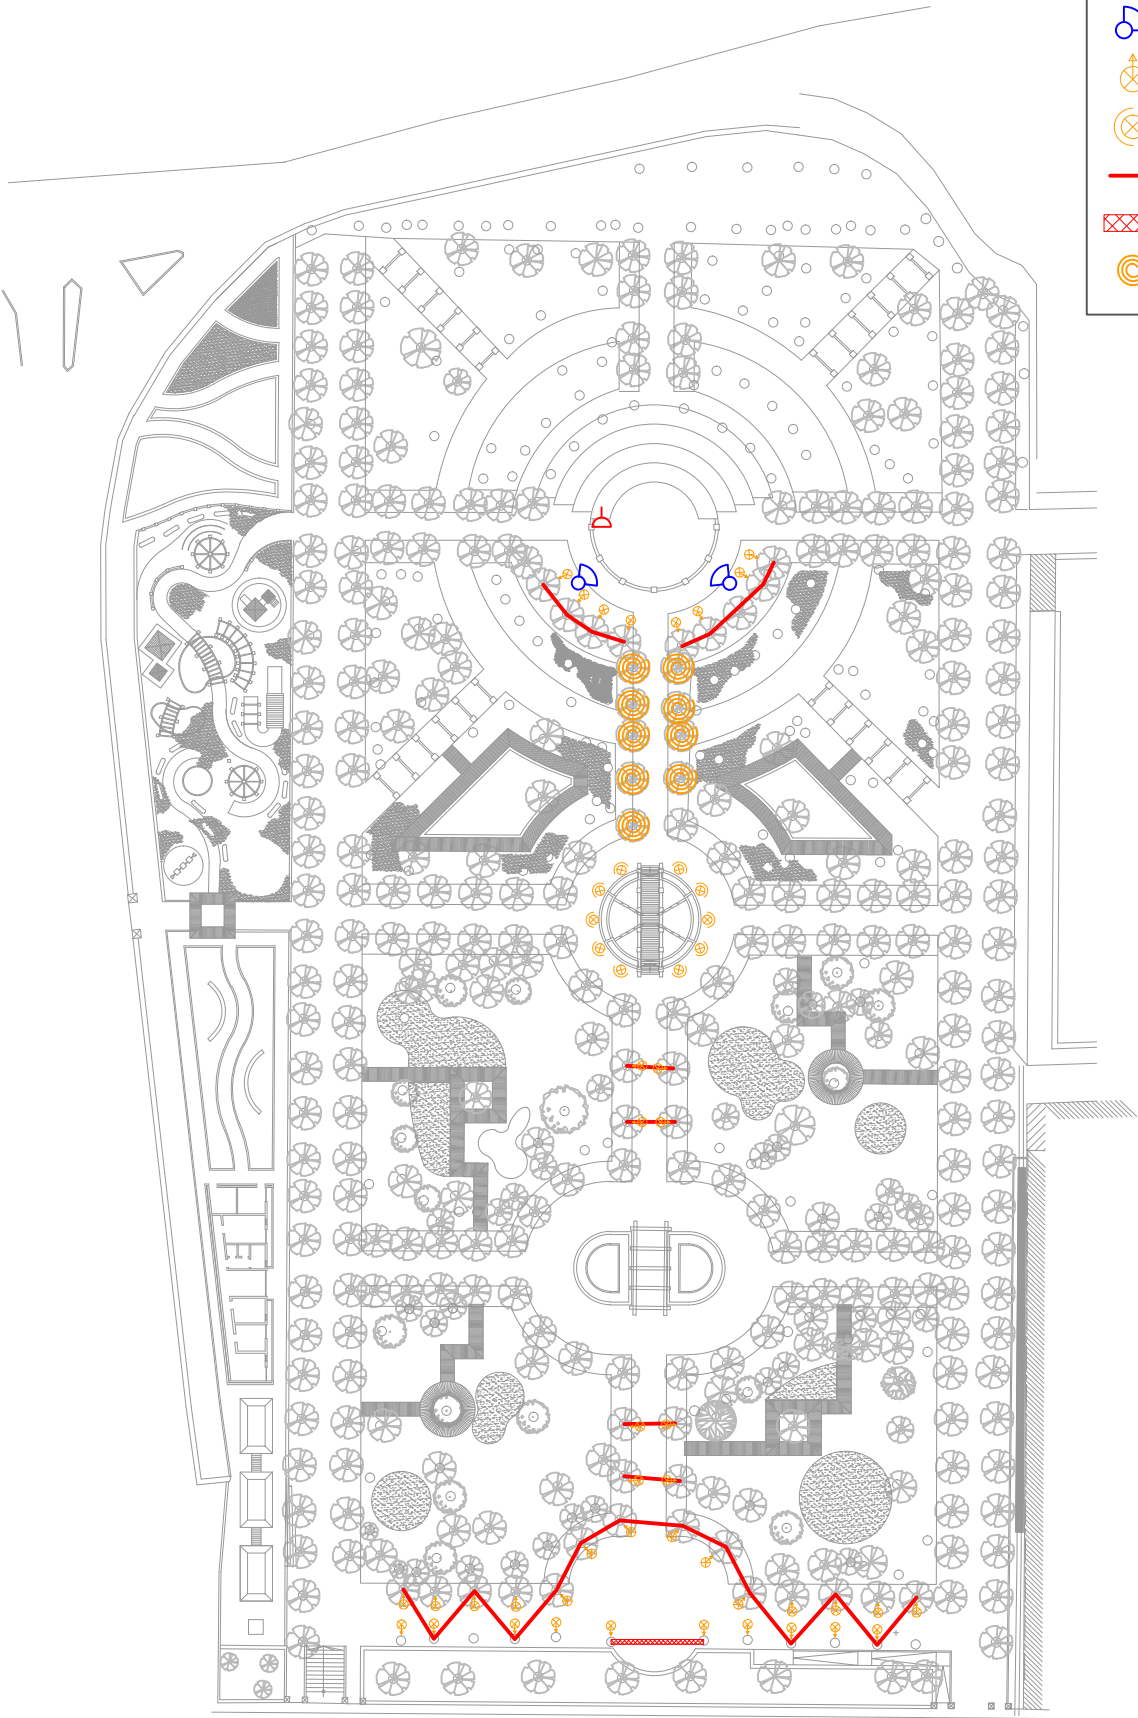


-  3-PHASE 16A SOCKET OUTLET
-  SPEAKERS
-  A) UPLIGHTERS
-  B) SPOTLIGHTS
-  C) LIGHT BANNERS
-  D) LIGHT CURTAIN
-  E) LED STRING LIGHTS



PROJECT TITLE :		VILLA RUNDLE	
CLIENT :		MINISTRY OF GOZO	
DRAWING TITLE :			
PA & DECORATIVE LIGHTING LAYOUT			
SCALE :	1:1000	SHEET SIZE :	A4
DATE :	02/01/2018	SHEET No :	1
Drawing in metres			